


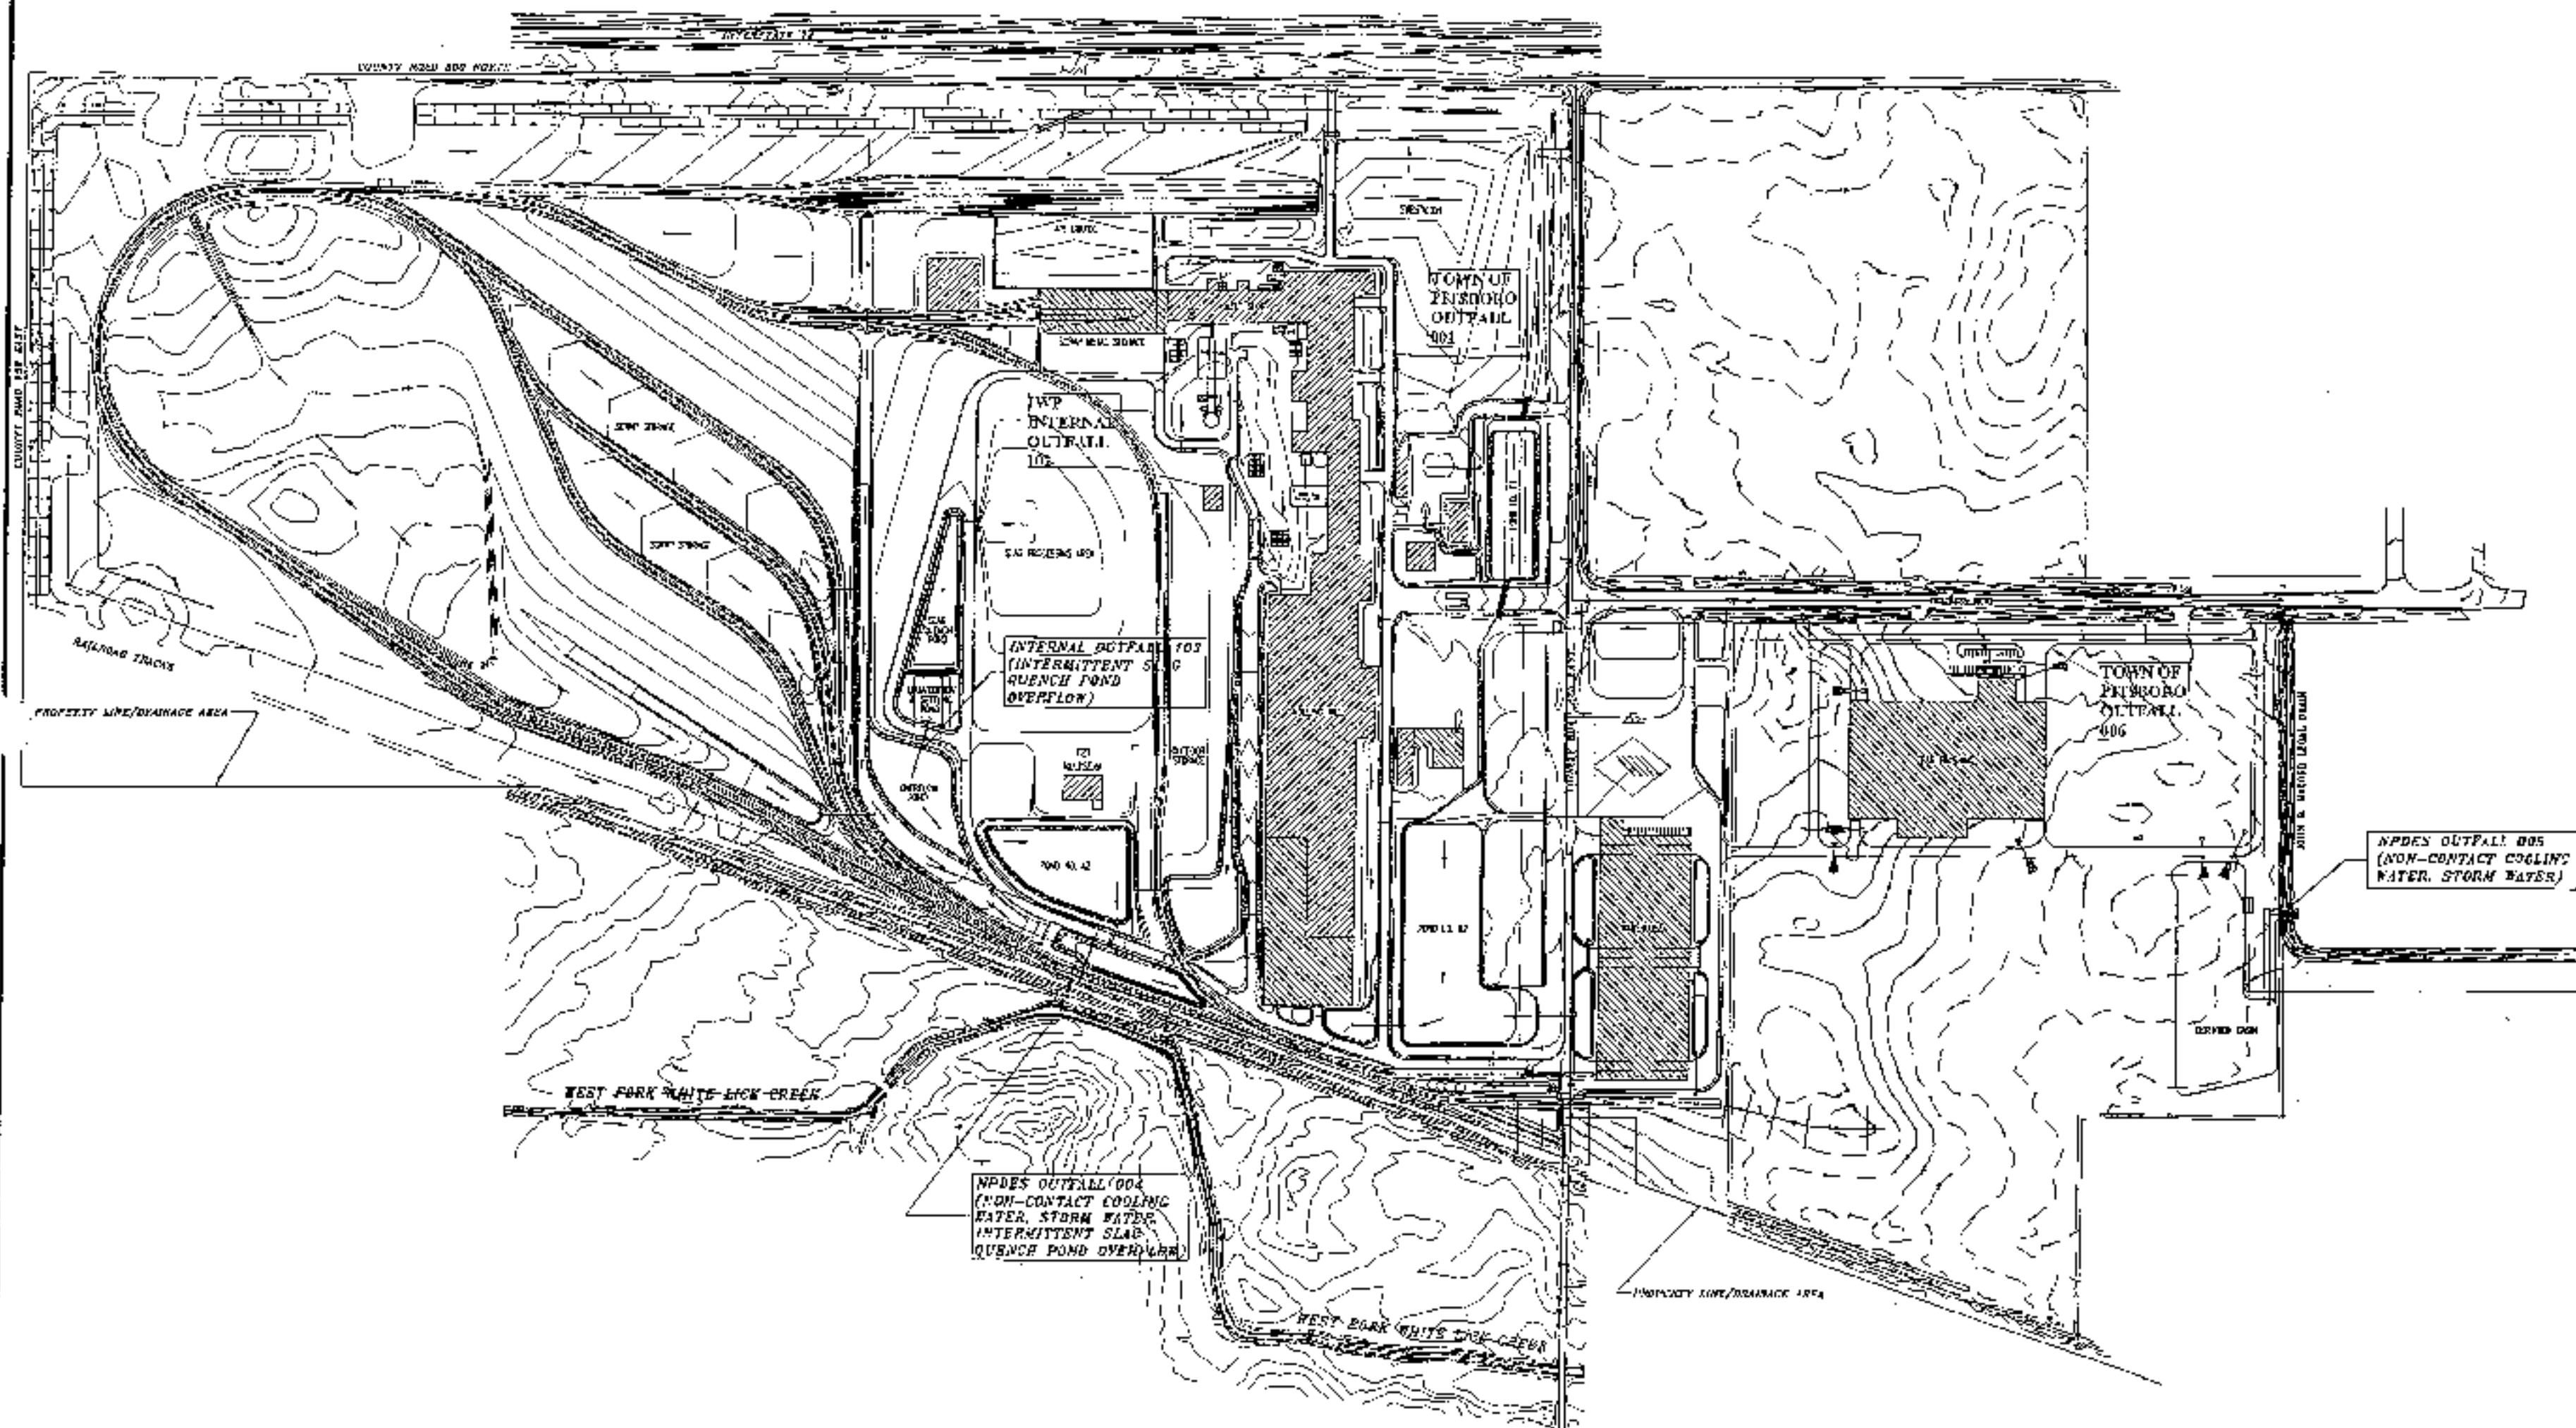

EES
ENGINEERING &
ENVIRONMENTAL
SOLUTIONS, LLC

3954 NEW VISION DRIVE
FORT WAYNE, IN 46815
(260) 469-4901
FAX (260) 469-4903

WWW.EESINC.COM

IWP PERMIT MODIFICATION
FOR

Steel Dynamics, Inc.

PITTSBORO, INDIANA

REVISIONS/NOTIFICATION:

SCALE:
N.T.S.

DATE
08/17/06

DRAWN BY
J.L. HENDRICKSON

DESIGNED BY
R.T. MEINHOLZ


REVIEWED BY
R.T. MEINHOLZ

PROJECT NUMBER:
06-125-15


FACILITIES
SITE PLAN


DRAWING NUMBER:
FSP-1

© 2006, EES, LLC

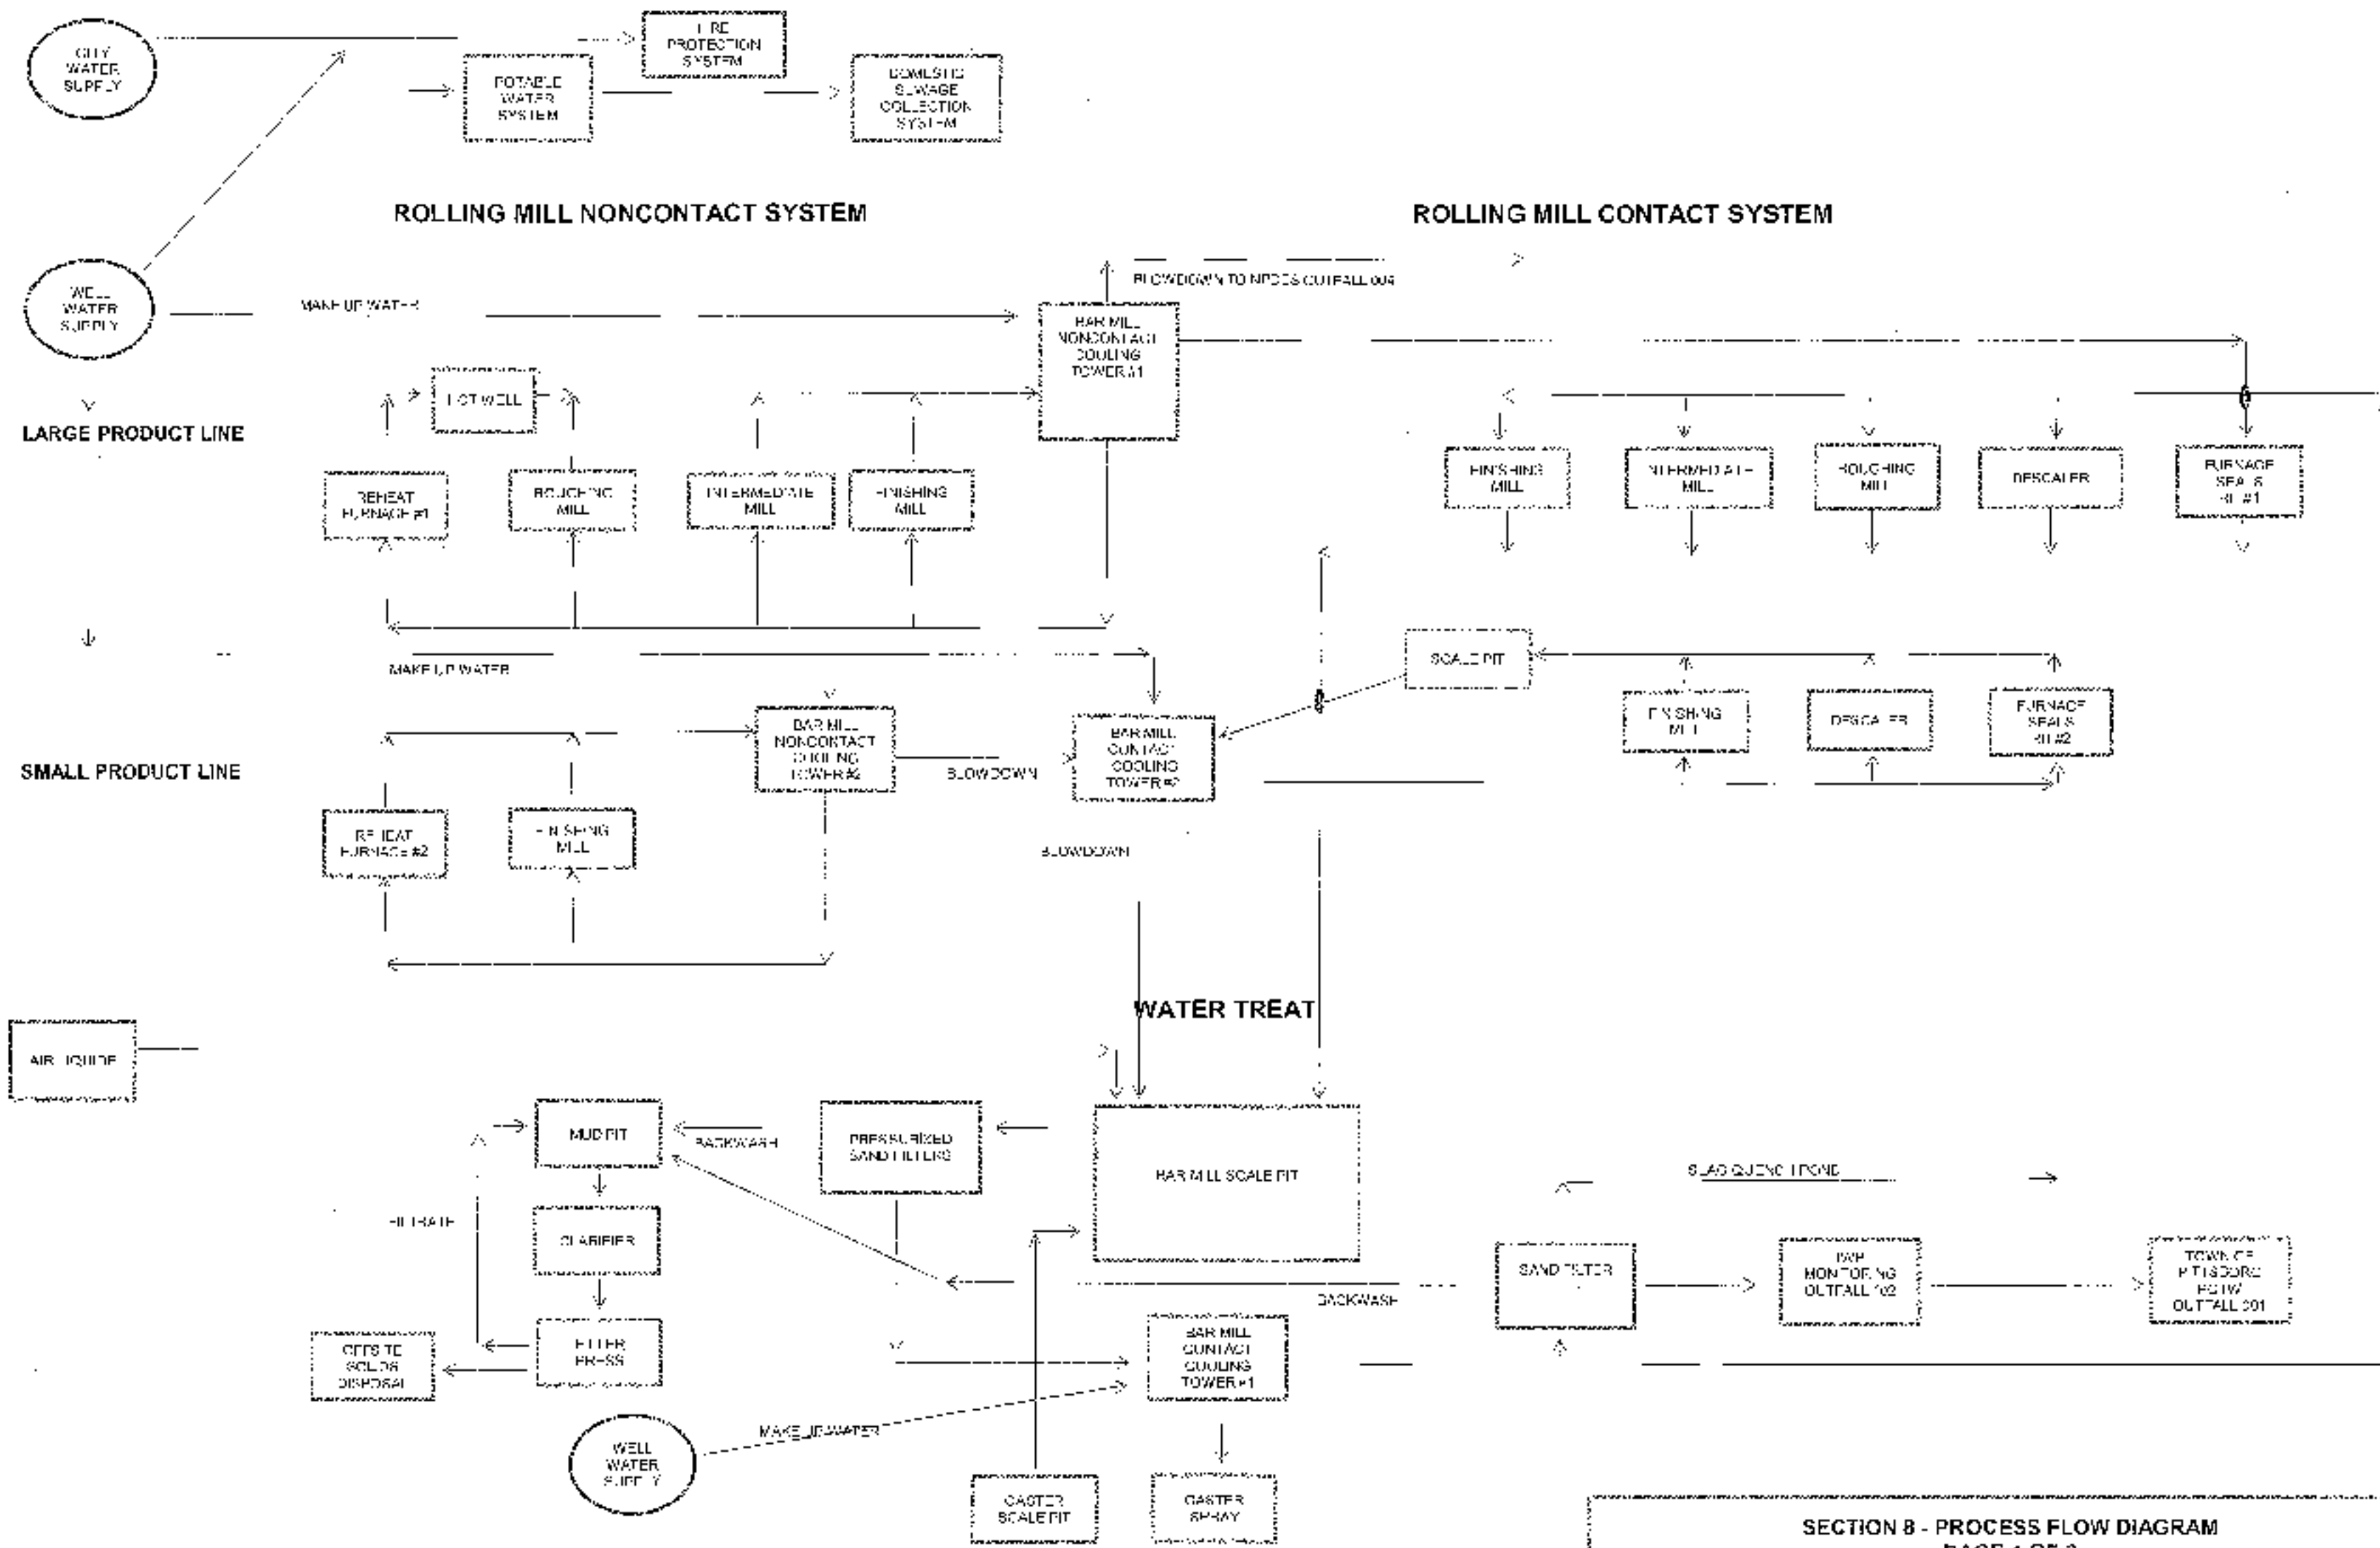


SEE PAGE 2 - MILL SHOP CONTACT SYSTEM

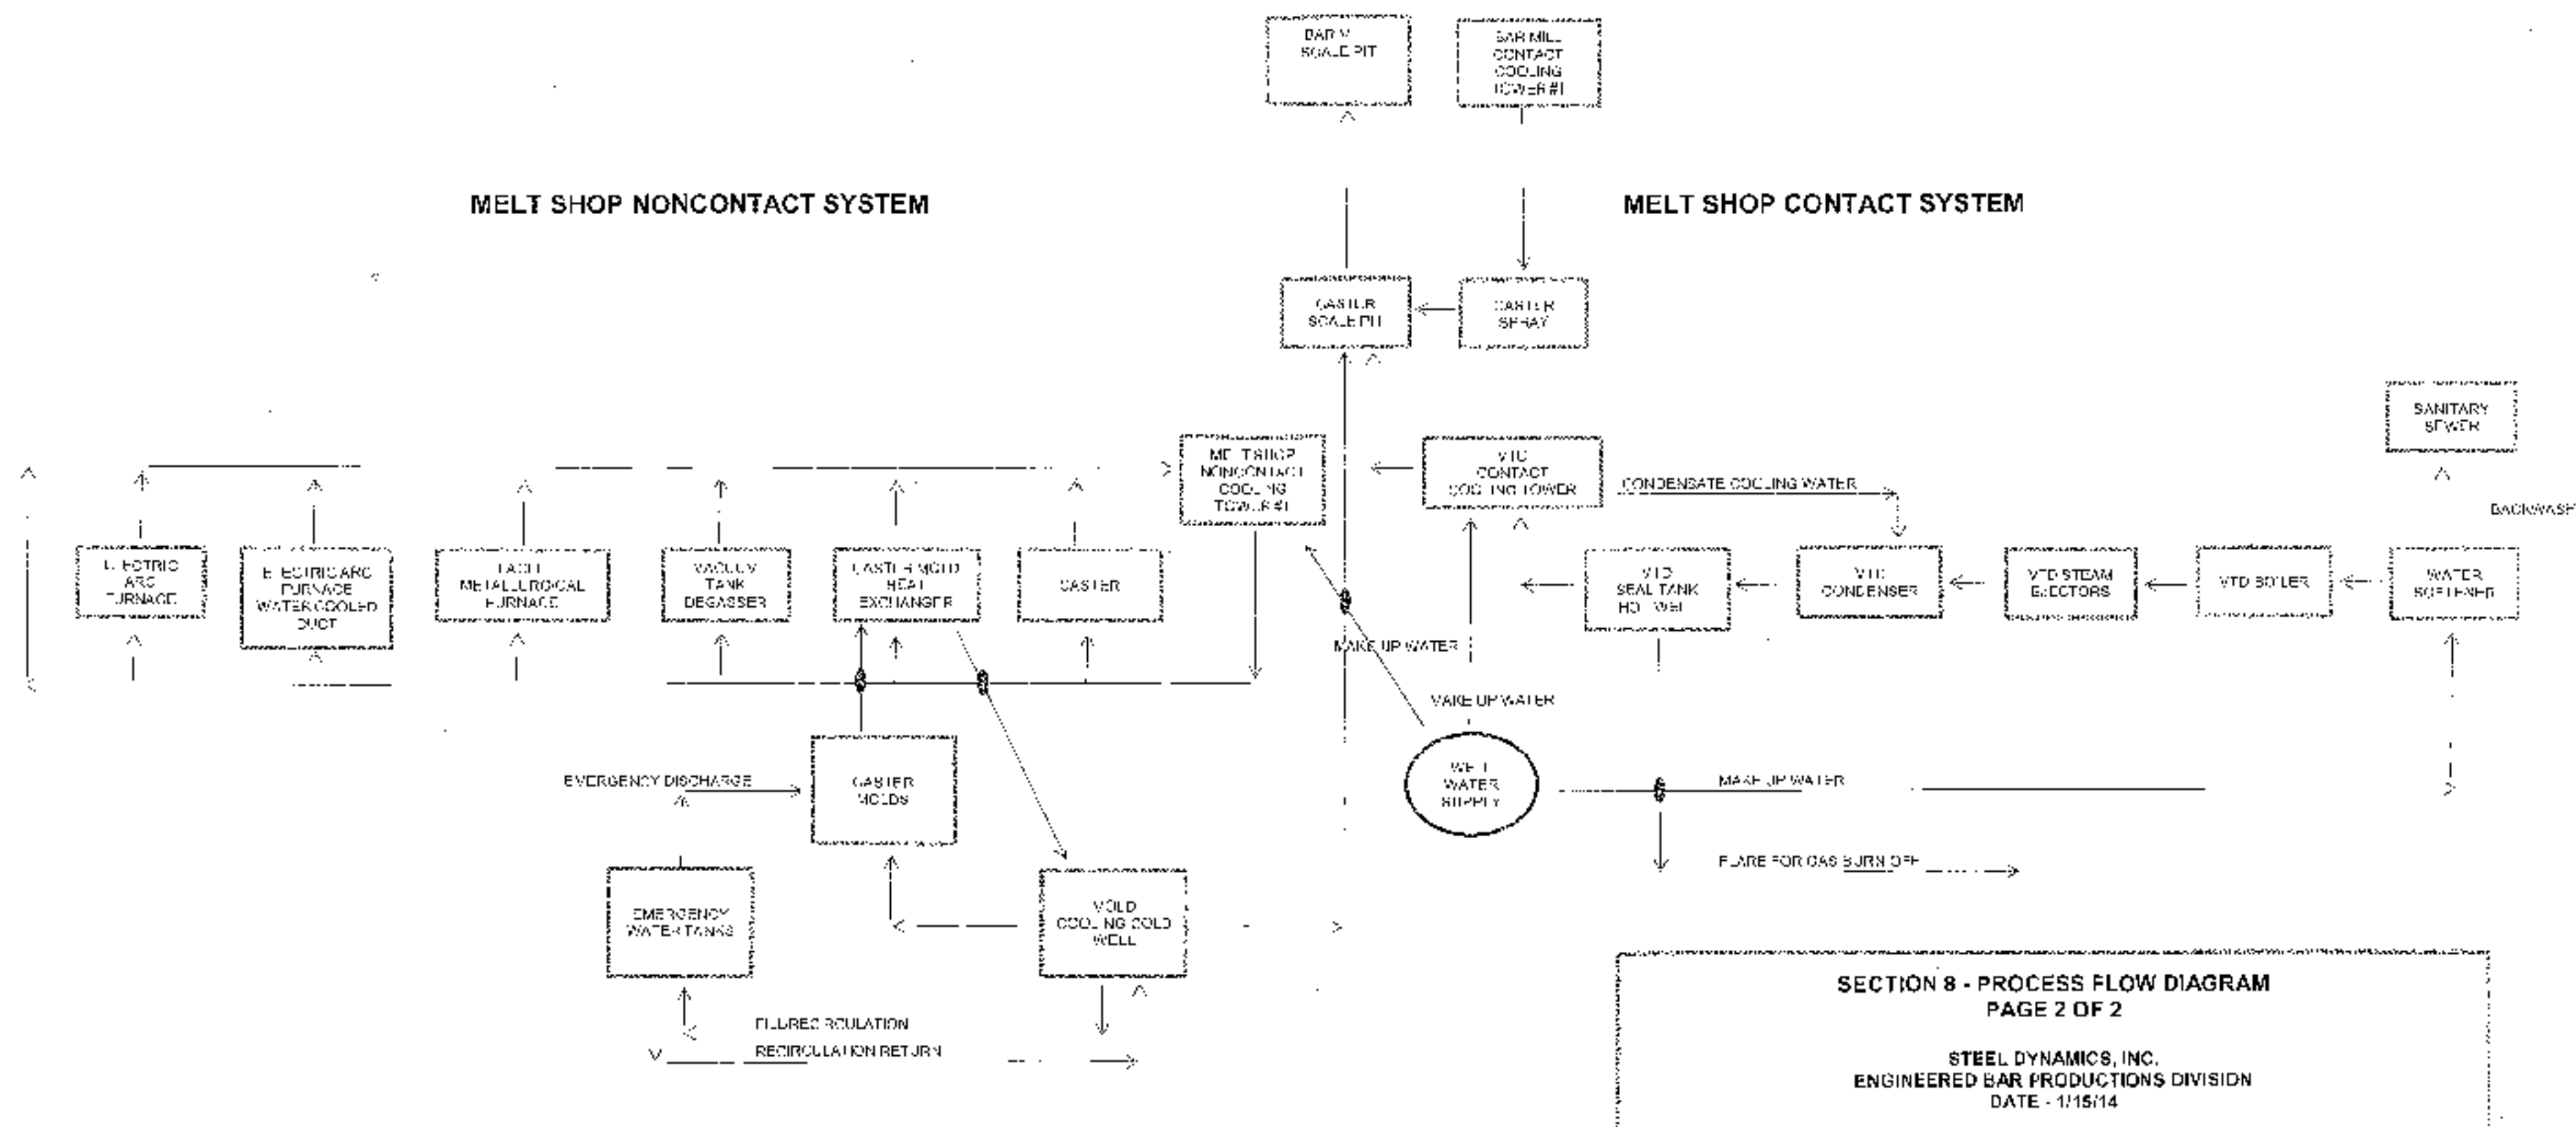

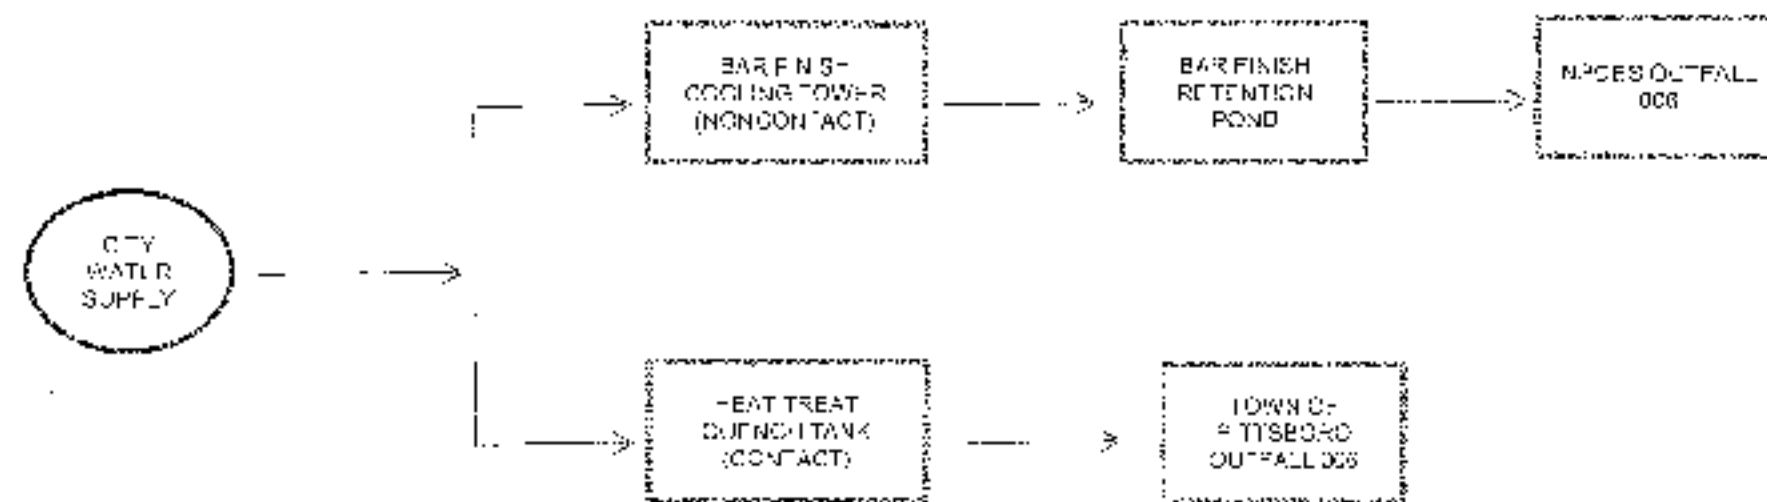

**SECTION 8 - PROCESS FLOW DIAGRAM
BAR FINISH**

STEEL DYNAMICS, INC.
ENGINEERED BAR PRODUCTIONS DIVISION
DATE - 1/15/14

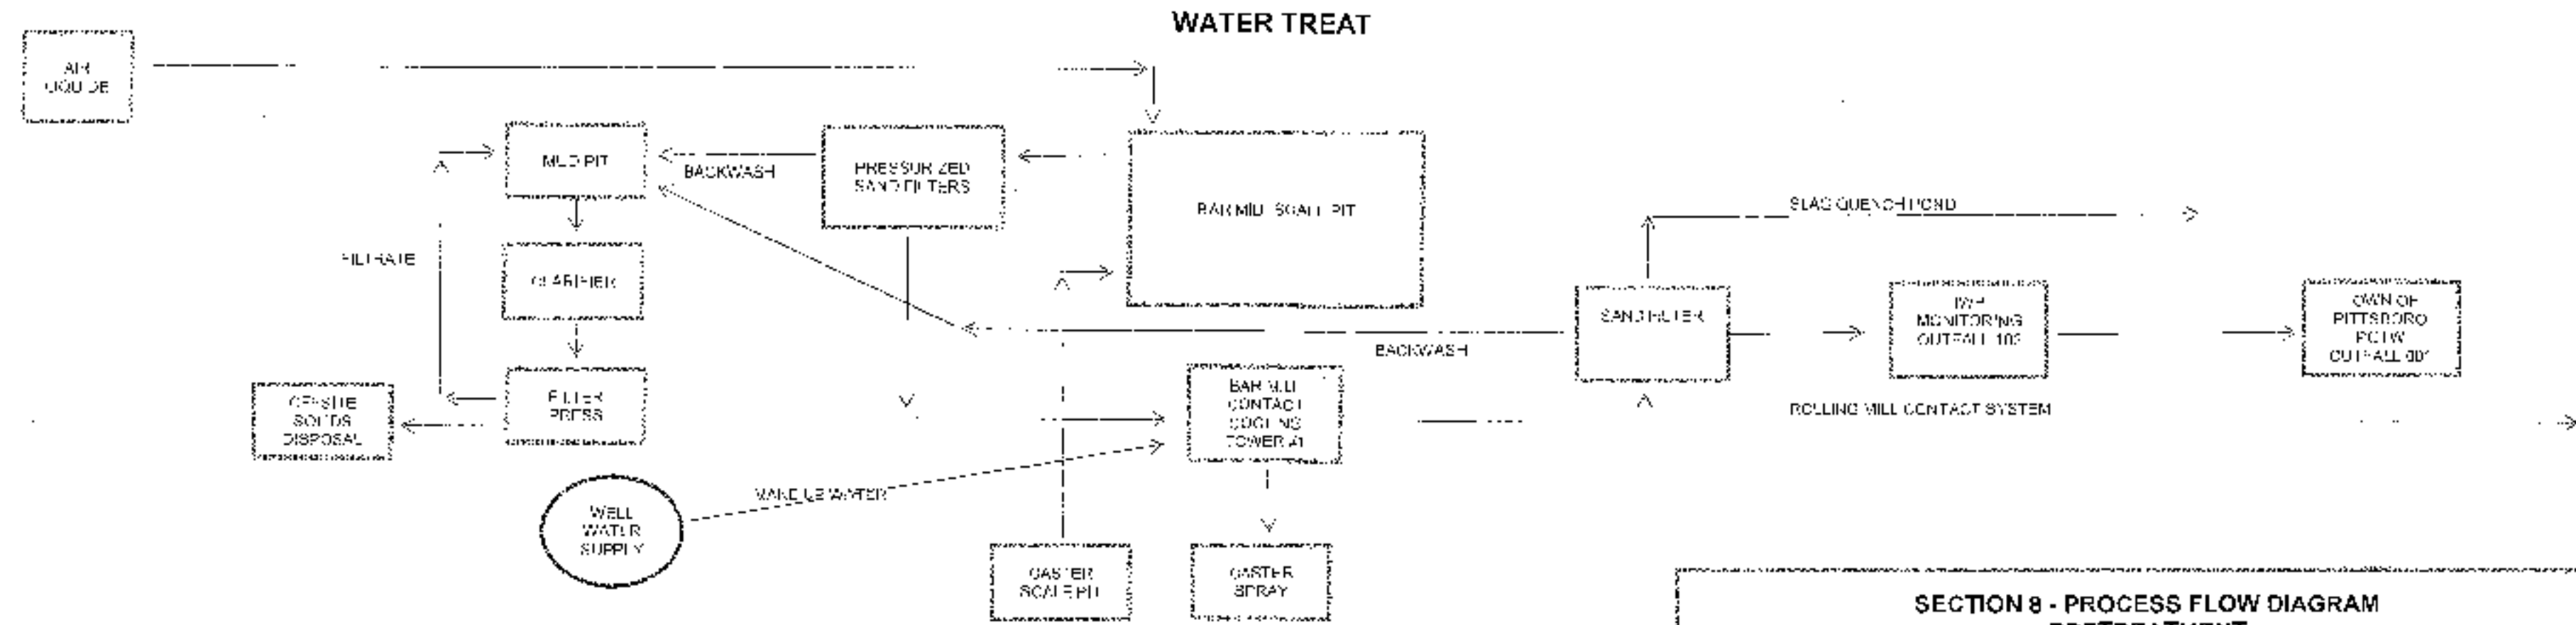

SEE PAGE 2 MELT SHOP CONTACT SYSTEM

**SECTION 8 - PROCESS FLOW DIAGRAM
PRETREATMENT**

STEEL DYNAMICS, INC.
ENGINEERED BAR PRODUCTIONS DIVISION
DATE - 1/15/14